


ROOF STRUCTURE SECTION
SCALE 1:20

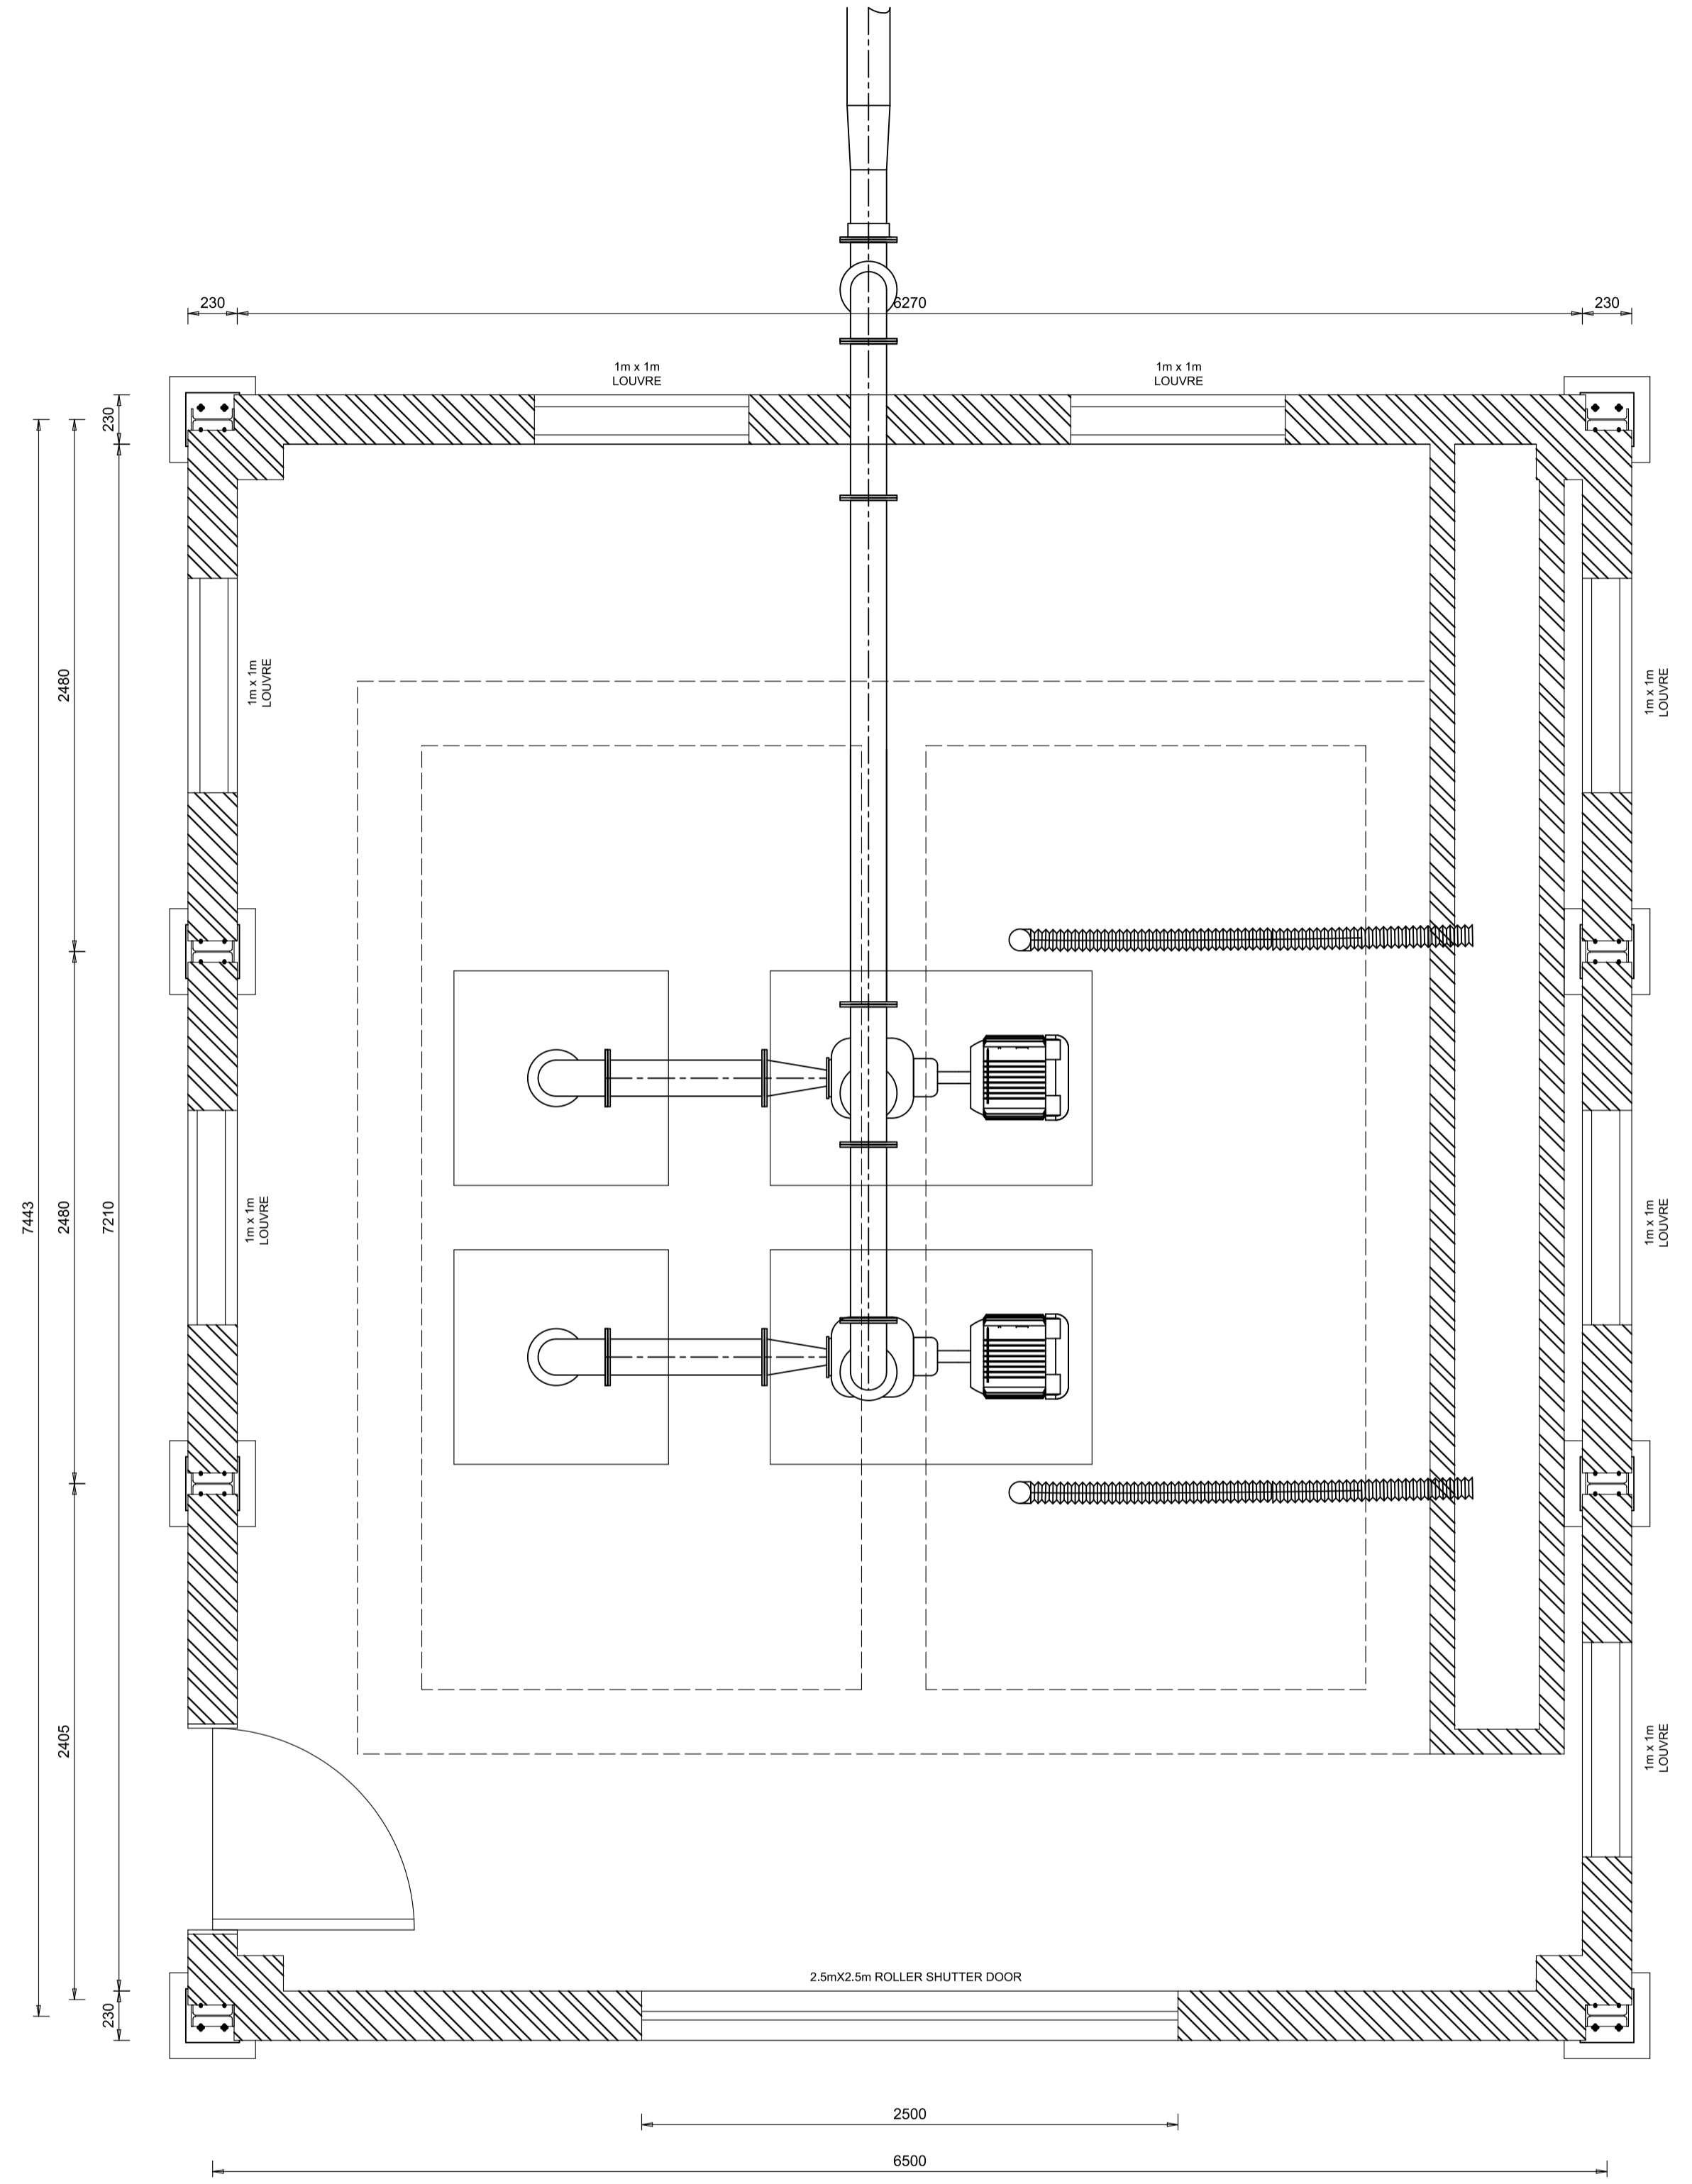

DRAWING NOT PRINTED TO SCALE REDUCED FROM A1 TO A3.

NOTE / LEGENDS	
ISSUE DATE: 25 Jul 2023	DRAWING SIZE: A1
REVISION: 0	
PRELIMINARY INFO ONLY	
X FOR TENDER	
FOR CONSTRUCTION	
AS-BUILT	

APPROVED BY COUNCIL / CLIENT		
CITY ENGINEER / CLIENT	REG. NO.	DATE
AMENDMENTS CODE		
A,B,C... : BEFORE TENDER	/A : BY CLIENT	
0 : TENDER DRAWING	/B : BY ARCHITECT	
1,2,3... : AFTER TENDER	/C : BY MECHANICAL OR ELECTRICAL	
Z : AS BUILT	/D : BY BVI	
	/E : BY OTHER ()	

DATE	INITIAL	No./CODE	REVISION DESCRIPTION
PEN 3	PEN 3	PEN 3	PEN 3
COPYRIGHT			
THIS DRAWING IS THE PROPERTY OF BVI - CONSULTING ENGINEERS IS PRIVATE AND CONFIDENTIAL AND IS SUPPLIED ON THE EXPRESS UNDERSTANDING THAT IT IS NOT TO BE USED FOR ANY PURPOSE OR COPIED OR COMMUNICATED TO ANY PERSON WITHOUT THE WRITTEN PERMISSION OF THE PROPRIETORS.			

CLIENT



NAMA KHOI MUNICIPALITY

bvi ENGINEERING PROCUREMENT MANAGEMENT

Uplington Office
Registration No. 1980002047

BBBEE Level 1

CESA

PROVINCE OFFICE

Free State: Maseru (012) 348-0099, Mafikeng (051) 447-2137, Welkom (057) 353-2499, Uplington (054) 337-8600

Northern Cape: Springbok (027) 712-8990

KwaZulu Natal: Durban (031) 286-6382, eThekweni (031) 786-0230

Eastern Cape: Port Elizabeth (041) 373-4343

Western Cape: Cape Town (021) 527-7000

E-MAIL: gsm@bvi.co.za, bfm@bvi.co.za, wfm@bvi.co.za, upl@bvi.co.za, spb@bvi.co.za, dm@bvi.co.za, emf@bvi.co.za, bke@bvi.co.za, qsp@bvi.co.za

PROJECT

REFURBISHMENT OF NABABEEP WWTP

DRAWING TITLE

NEW SUMP BUILDING MECHANICAL DETAILS

APPROVED BY BVI			
ENGINEER/TECHNOLOGIST	REG. NO.	DATE	
SCALE	AS SHOWN	DRAWN	S.BOSHOFF
DESIGNED	G.MEIRING	CHECKED	M. DU PLESSIS
PLAN NUMBER		REVISION NO.	DATE SAVED
LAYERS USED			
35008-201-02		0	25 Jul 2023

35008-201-01-0.dwg